



GROUND FLOOR - MALE LOCKER, FEMALE LOCKER, CUSTOM, SECURITY, WORKER'S ACCESS, LOCKER FEMALE TOILET, MALE TOILET, FIRE PUMP ROOM & FIRE TANK

SCALE 1:100

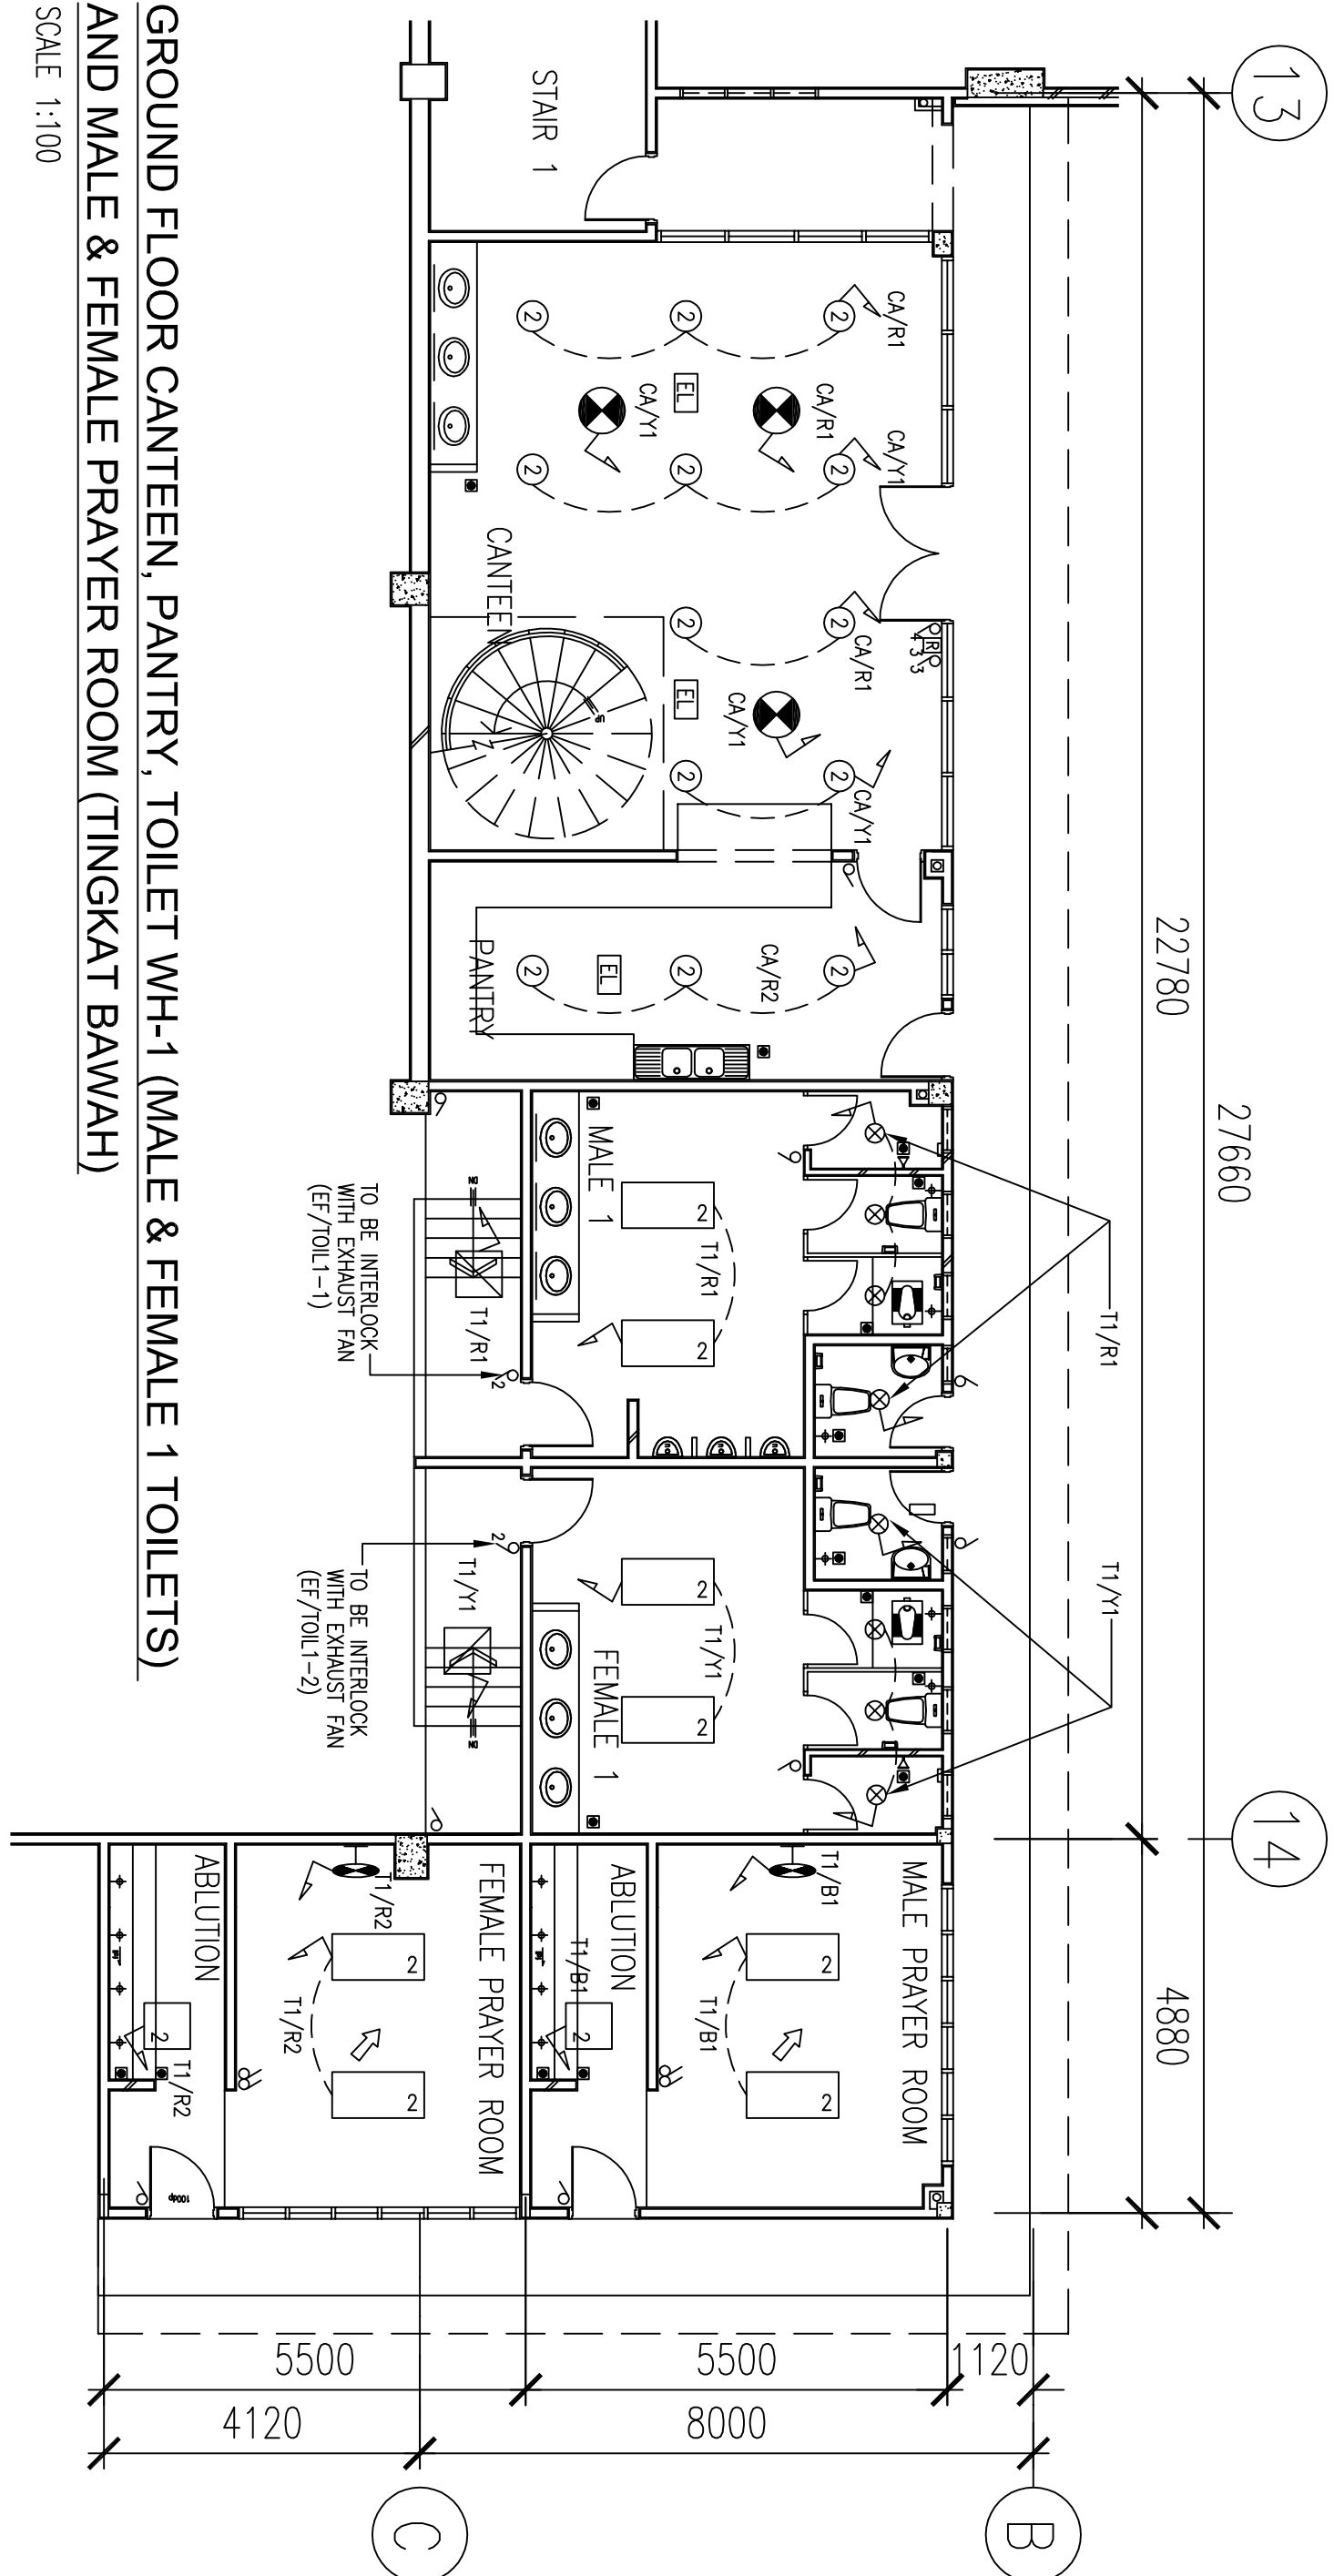

 

 
 

 



 


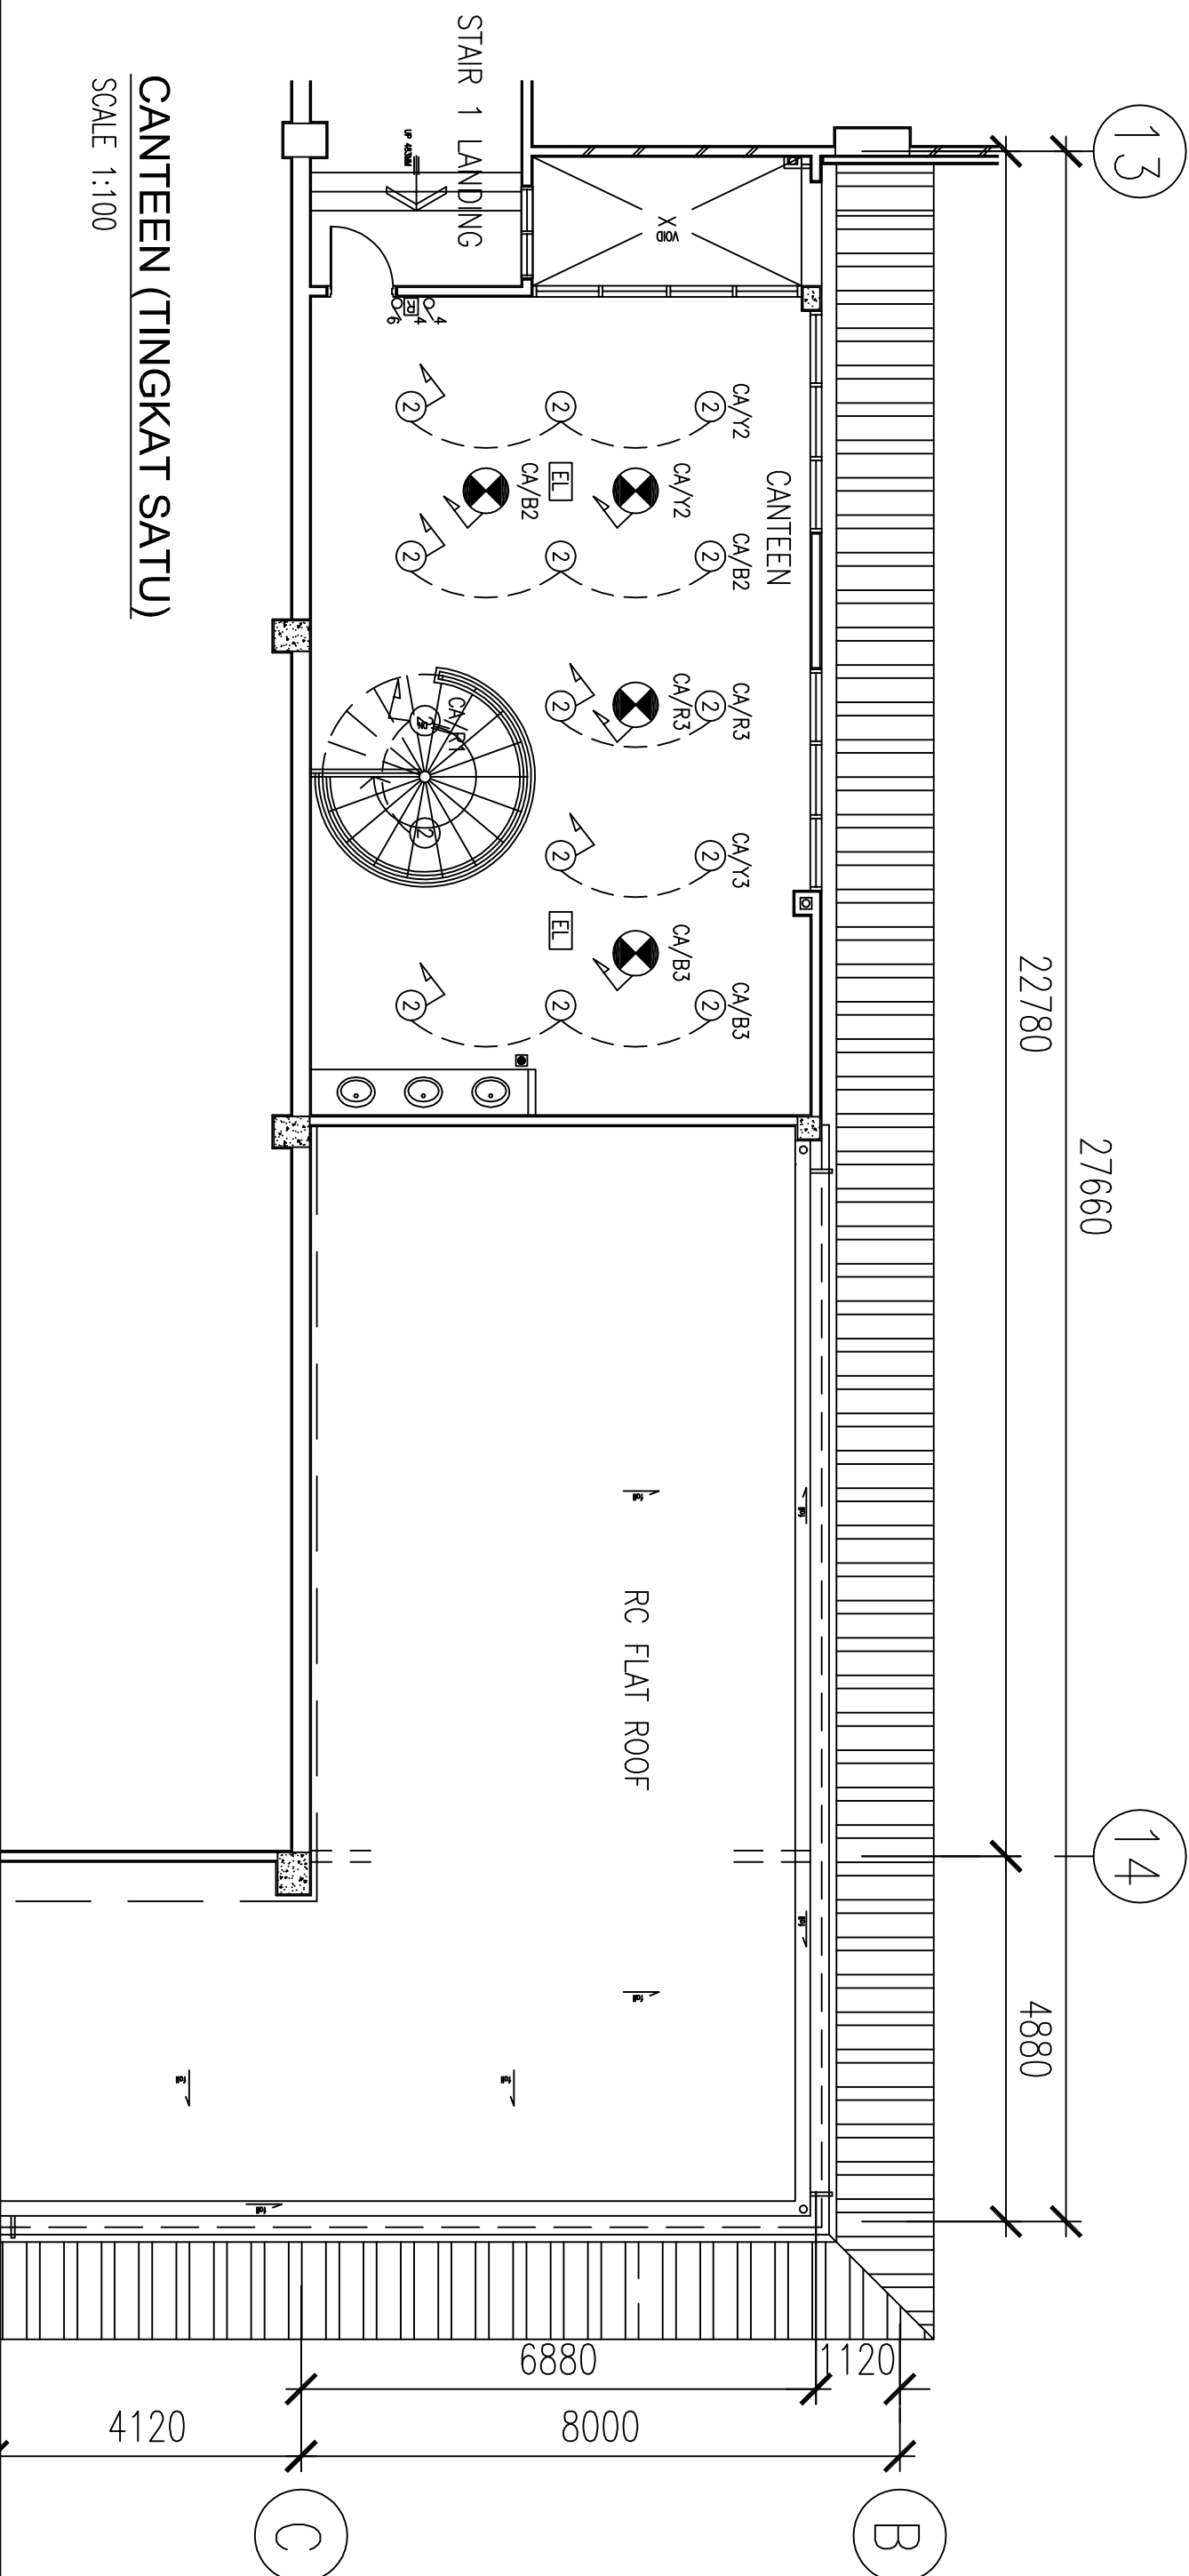


 
GROUND FLOOR CANTEEN, PANTRY, TOILET WH-1 (MALE & FEMALE 1 TOILETS)
AND MALE & FEMALE PRAYER ROOM (TINGKAT BAWAH)

SCALE 1:100



CANTEEN (TINGKAT SATU)

SCALE 1:100

	2.55W BARE CHANNEL FLUO. FITTING
	1.65W BARE CHANNEL FLUO. FITTING
	1x18W BARE CHANNEL FLUO. FITTING
	2x36W RECESSED FLUO. LIGHT FITTING C/M ROLL MIRROR REFLECTOR LUGARE
	2x18W RECESSED FLUO. LIGHT FITTING C/M ROLL MIRROR REFLECTOR LUGARE
	18W P.C. RECESSED DOWN LIGHTING
	28W P.C. RECESSED DOWN LIGHTING
	28W CLOUDLINE SURFACE MOUNTED P.C. DOWN LIGHT
	SWITCH CENTRE
	6 5A SWITCH
	5A TWO WAY SWITCH
	1x15W RECESSED SELF CONTAINED EMERGENCY LIGHT
	2x15W SELF CONTAINED YELLOW* SIGN
	250W HBIAY LIGHT FITTING
	2 x 20W RECESSED P.C. DOWN LIGHT
	35W HALL MOUNTED FAN

LEGEND

2	14/07/08	REQUEST AS PER CEM COMMENT.	SYN
1	19/09/08	REQUEST AS PER LATEST REQUESTED DAYOUT	LOW
0	19/09/08	ISSUE TYPE CONSTRUCTION	LOW
NO.	DATE	REMARKS	OTHER

TAJUK PROJEK :

CADANGAN MEMBINA SEBUAH GUIDANG,
1 TINGKAT BERSERTA 3 TINGKAT,
YANG MENGANDUNGI:-
PENCAMWANG ELEKTRIK TNB,
PUSAT PENGUMPULAN SAMPAH,
BILIK PAM,
1 UNIT PONDOK PENGAWAL DAN
1 UNIT RUANG MENUNGU 1 TINGKAT,
DI ALAMAT NO 9 (PT 33271)
JALAN TANG UB92,
SEKSYEN UB,
PERINDUSTRIAN BUKIT JELUTONG,
40160 SHAH ALAMI,
SELANGOR DARUL HESAN

UNION
TETUAN ORYX IMPRESSIONS SDN. BHD.

TANDATANGAN & ALAMAT PEMILIK :

ORX IMPRESSIONS SDN. BHD. (co. no. 646594-X)
36-2, JALAN 5/101C, OFF JALAN KASKAS,
JALAN CHERAS, 56100 KUALA LUMPUR.
TEL: 03- 9132 3018 FAX: 03-9132 7018

ARKITEK ::



GRA ARCHITECTS S078 A&O
 6-15-01 Tower 2, Menara PGRM, no. 6&8 Jalan Pudu Ulu, 56100 Kuala Lumpur, Malaysia
 T 603-9281 7177 F 603-9287 8208 E gfram@gra.com.my www.gra.com.my

JURUTERA M&E :



PERUNDING ATOZ
Jurnal Perunding - Consulting Engineers

LEVINSON MIOZ
Jurubens Perandun - Consulting Engineers

23B, JALAN SSI/5/4C, 47500 SUBANG JAYA, SELANGOR DARUL EHSAN
Tel: 03-56356711 Fax: 03-56355177 E-mail: perunding_atoz@myjoring.net

TAJUK LUKISAN :

WAREHOUSE - ANNEX BUILDING

LIGHTING LAYOUT (SHEET 1 OF 2)

DILOKIS	DISEMAN
FFL	SHB

SKALA	1 : 100	TARIKH	FEB 200
-------	---------	--------	---------

INC. LONDON
508307/E/LSP/04

kontraktor hendaklah mengikut dimensi yang ada di dalam rajah, segala dimensi mesti diperiksa dan disemak di tapak binaan, sebarang selisihan yang terdapat hendaklah dilaporkan kepada dikte/jurutera yang berkuasa.